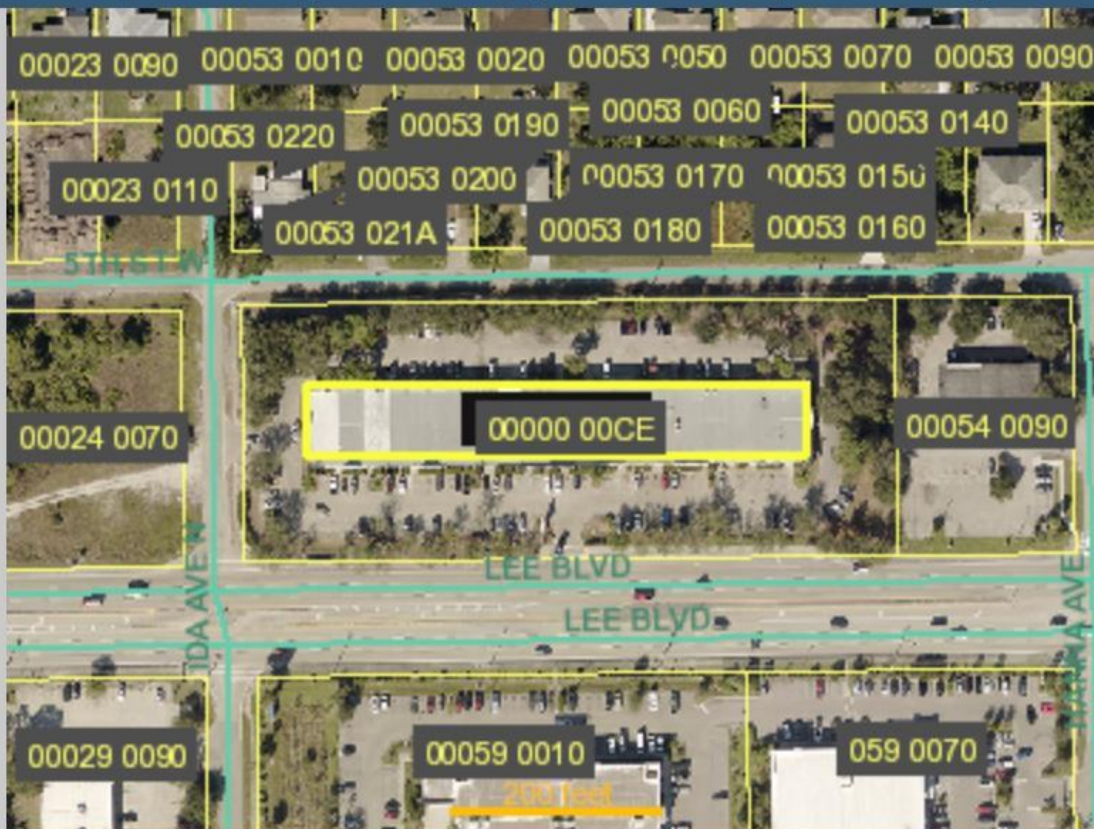


[Tax Map Viewer] [View Comparables]**[Pictometry Aerial Viewer]****Image of Structure**

◀ Photo Date January of 2008 ▶ ☐ View other photos

This picture represents the complex and may not represent the building that the unit is in.

EQUIP. LEGEND & AREA OF RESPONSIBILITY

ITEM	DESCRIPTION	MODEL	NSF	SUPPLIER	INSTALLATION	COORD./SUPERVISED	REMARKS
				OWNER CONT.	OWNER CONT.	BY CONTRACTOR	
01	DOUBLE GLASS DOOR MERCHANDISER	RM-45-SD	X	X	-	X	115 VOLTS, 11.8 AMPS / WITH CASTORS / NOTE 09
02	PASS-THRU COUNTER	CUSTOM	-	X	-	X	-
03	SANDWICH/SALAD UNIT	SR48A-8	X	X	-	X	115 VOLTS, 11.8 AMPS / WITH INTEGRAL SHELVING #38 / NOTE 09
04	1-DR. REACH-IN REFRIGERATOR	R1A-FS	X	X	-	X	115 VOLTS, 4.0 AMPS / WITH CASTORS / NOTE 09
05	48" WOODEN BENCH	CUSTOM	N/A	X	-	X	-
06	HOOD FIRE ANSUL SUPPRESSION SYSTEM	EXISTING	N/A	X	-	X	CONTRACTOR TO MODIFY AS NECESSARY UNDER SEPARATE FIRE SUPPRESSION PERMIT
07	S.S. 3-COMPARTMENT SINK, 96"L.	CUSTOM	X	X	-	X	WITH (2) 18" DRAIN BOARDS, (2) 8" SIDE SPLASHES VERIFY W/ LOCAL JURISDICTIONS FOR DRAIN BOARD & BOWL SIZE.
08	MOP SERVICE BASIN	MSB-2424	X	-	X	-	WITH BUILT-IN ANTI SIPHON DEVICE
09	S.S. WORK TABLE 30"D. x 36"L.	CUSTOM	X	X	-	X	WITH DRAWER / WITH INTEGRAL SHELVING #38 / WITH CASTORS
10	S.S. WORK TABLE 30"D. x 96"L.	CUSTOM	X	X	-	X	WITH UNDERSHELF / WITH INTEGRAL SHELVING #38
11	S.S. WORK TABLE 30"D. x 18"L.	CUSTOM	X	X	-	X	24" TALL
12	HAND SINK W/ SIDE SPLASH (R & L)	7-PS-66	X	X	-	X	WITH (2) 8" HIGH SIDE SPLASHES
12B	HAND SINK W/ SIDE SPLASH (R & L)	PBHS-WK/VMB-SSP-X	X	X	-	X	WITH (2) 8" HIGH SIDE SPLASHES
13	POTATO SLICER	300 SERIES	X	X	-	X	WITH SHOVEL LEVER
14	ICE MACH. W/ STORAGE BIN	KM-520MAJ	X	X	-	X	115 VOLTS, 1PH, 11 AMPS / S.B. MODEL: B500PF / WITH 6" HIGH LEGS
14A	ICE MACH. FILTER	CUSTOM	X	X	-	X	SUPPLIED BY EQUIPMENT VENDOR
15	TANKLESS WATERHEATER	1991-DV	X	-	X	-	REFER TO PLUMBING PLANS FOR SPECIFICATIONS
16	SWING GATE	CUSTOM	-	X	-	X	-
17	NOT USED	-	-	-	-	-	-
18	SOLSTICE SUPREME GAS FRYER	SSH75	X	X	-	X	105,000 BTU, 75 LBS (OIL CAPACITY) / WITH 6" CASTORS
19	NOT USED	-	-	-	-	-	-
20	COOKING & HOLDING TIMER	U160DKB7503	X	X	-	X	-
21	SOLSTICE SUPREME FILTER	SFSH75	X	X	-	X	120 VOLTS, 6.2 AMPS / ITEM IS AN INTEGRAL PART OF THE FRYERS
22	STEAM TABLE PAN RACK & COVER	1509/PRC 12	X	X	-	X	QUANTITY: 02 / NOT INDICATED ON PLAN
23	NOT USED	-	-	-	-	-	-
24	NOT USED	-	-	-	-	-	-
25	24" x 30" TABLE & BASE	CUSTOM	N/A	X	-	X	-
26A	30" x 42" TABLE & BASE	CUSTOM	N/A	X	-	X	-
26B	ACCESSIBLE 30" x 42" TABLE & BASE	CUSTOM	N/A	X	-	X	-
27	WOOD CHAIR	6305P	N/A	X	-	X	-
28	TEA DISPENSER	BIB	X	X	-	X	120 VOLTS, 60HZ, 25-125 PSI
28A	NOT USED	-	-	-	-	-	-
29	SULIM JIN TRASH RECEPTACLE	8323G4	X	X	-	X	-
30	SANITARY NAPKIN RECEPTACLE	1102	X	X	-	X	-
31	TRASH RECEPTACLE	MODEL VARIES	X	X	-	X	-
32	BEVERAGE / CONDIMENTS COUNTER	CUSTOM	N/A	X	-	X	PROVIDED OWNER AND INSTALLED BY CONTRACTOR
33	SHORTENING SHUTTLE	SS-611-T	X	X	-	X	ITEM NUMBER NOT INDICATED ON EQUIPMENT PLAN
34	FREESTYLE DISPENSER	COCA COLA	X	X	-	X	115 VOLTS, 20 AMPS / GROUNDED DUPLEX OUTLET
34A	FREESTYLE DISPENSER FILTER	COCA COLA	X	X	-	X	PROVIDED BY COCA COLA
35	CARBONATOR	N/A	N/A	X	-	X	SUPPLIED BY COCA COLA PRODUCTS
36	BIB FLEX RACK SYSTEM	44239	X	X	-	X	WITH 6" HIGH LEGS
37	CO2 SYSTEM	CARBO-MIZER 450	N/A	X	-	X	-
38	SOLID SHELVES	CUSTOM	X	X	-	X	2 ROWS INTEGRAL W/ #03 & 10. REFER TO EQ.2 FOR HEIGHT
39	DRY STORAGE SHELVING	EG01.00	X	X	-	X	REFER TO EQUIPMENT PLAN FOR SIZES AND NUMBER OF TIERS
40	DUNNAGE RACK (PRODUCE STAND)	DR362012	X	X	-	X	-
41	SCULLERY SHELVING (2 ROWS)	EG01.00	X	X	-	X	2 ROWS OF 18" x 48" (TOP), 2 ROWS OF 18" x 38" (BOTTOM)
42	11"-0" TYPE 1 EXHAUST HOOD	EXISTING	X	X	-	X	NOTES 05, 06, 07- VERIFY TYPE, SIZE & SERIES AGAINST HOOD DRAWINGS
43	S.S. WORK TABLE 48" (FRY TABLE)	CUSTOM	X	X	-	X	-
44	BROOM & MOP RACK	40731	X	X	-	X	-
45	FIRE EXTINGUISHER	REFER NOTE 03	N/A	-	X	-	CLASS: K (AT HOOD), CLASS: 2A10BC (STANDARD)
46	POINT-OF-SALE SYSTEM	RZ-X750	N/A	X	-	X	-
46A	NOT USED	-	-	-	-	-	-
47	SMARTRACK 12U WALL-MOUNT RACK	SRW9U	X	X	-	X	NOTE 11
48	POINT-OF-SALE EQUIPMENT	-	N/A	X	-	X	WALL MOUNTED MANAGER STATION
49	SAFE & STAND	P060413-03	N/A	X	-	X	MOUNTED ON BASE AS REQUIRED / COORDINATE TYPE WITH OWNER
50	STEREO (AMP.) RECEIVER	MODEL VARIES	N/A	X	-	X	PROVIDED AND INSTALLED BY OWNER
51	SATELLITE RECEIVER	MODEL VARIES	N/A	X	-	X	PROVIDED AND INSTALLED BY OWNER
52	LOW WALL CAP	CUSTOM	N/A	-	-	-	PROVIDED OWNER AND INSTALLED BY CONTRACTOR
53	1/2 PAN X 4"	#5124	N/A	X	-	X	PROVIDED OWNER AND INSTALLED BY CONTRACTOR
54	POS COUNTER	CUSTOM	N/A	X	-	X	PROVIDED OWNER AND INSTALLED BY CONTRACTOR
55	POS SHROUD	CUSTOM	N/A	X	-	X	-
56	STAINLESS STEEL FLEX HOSE	CUSTOM	X	X	-	X	-
57	EXTERIOR BUILDING SIGNAGE 'WINGSTOP'	CUSTOM	N/A	X	-	X	PROVIDED AND INSTALLED BY THE SIGN VENDOR.
58	T.V. WALL BRACKET & STAND	MODEL VARIES	N/A	X	-	X	-
59A	HAND SOAP DISPENSER	S4025	N/A	X	-	X	-
59B	NOT USED	-	-	-	-	-	-
60A	ELECTRIC HAND DRYER	M17ACS-UL	N/A	X	-	X	-
60B	PAPER TOWEL DISPENSER	T1290WS	N/A	X	-	X	-
61	S.S. FRAMED MIRROR	B-165-2436	N/A	-	X	-	SIZE: 24" x 36", WITH S.S. CHANNEL FRAME
62	36" x 1 1/2" GRAB BAR	B-6106	N/A	-	X	-	-
63	42" x 1 1/2" GRAB BAR	B-6106	N/A	-	X	-	X
64	TOILET PAPER DISPENSER	8735020	N/A	X	-	X	-
65	GREASE INTERCEPTOR	MODEL VARIES	N/A	-	X	-	REFER PLUMBING DRAWINGS FOR SPECIFICATIONS
66	NOT USED	-	-	-	-	-	-
67	WALL MOUNTED MIXING FAUCET	CUSTOM	X	X	-	X	-
68	WIRE WALL SHELVING	METRO	X	X	-	X	REFER TO EQ1 FOR SIZE
69	COOLER DUNNAGE RACK	DR362012	X	X	-	X	REFER TO EQUIPMENT PLAN FOR SIZES & MOUNTING HEIGHTS
70	COOLER SHELVING	EG01.00	X	X	-	X	5 TIERS HIGH. REFER TO EQUIPMENT PLAN FOR SIZES
71	WALK-IN COOLER	CUSTOM	X	X	-	X	NOTE 09 / WSPROTO-1
72	STOREFRONT VINYL GRAPHICS	CUSTOM	N/A	X	-	X	-
73	KNIFE HOLDER	2918P	X	X	-	X	-
74	TO-GO RACK	CUSTOM	X	X	-	X	18x36, 4 TIER WITH SOLID SHELVES AND 6" CASTERS
75	TICKET RAIL	X	X	-	X	-	-
76	HIGH CHAIR	CHH-104	N/A	X	-	X	-
77	S.S. 2-COMPARTMENT SINK, 60"L.	CUSTOM	X	X	-	X	WITH (1) 18" DRAIN BOARDS, (2) 8" SIDE SPLASHES WITH OPTIONAL LID COVERS. VERIFY W/ LOCAL JURISDICTIONS FOR DRAIN BOARD & BOWL SIZE.
78	DRY STORAGE WIRE SHELVING	EG01.00	X	X	-	X	REFER TO EQUIPMENT PLAN FOR SIZES
79	COMMERCIAL MOP BUCKET	7580-88	N/A	X	-	X	ITEM NOT INDICATED ON EQUIPMENT PLAN
80A	24" OFFICE BAR STOOL	4202P	N/A	X	-	X	-
80B	NOT USED	-	-	-	-	-	-
81	CONDIMENT DISPENSER	CUSTOM	X	X	-	X	-
82	NOT USED	-	-	-	-	-	-
83	ICE MACHINE FOR FREESTYLE COKE	KMD-410MAJ	X	X	-	X	115V, 1 PH, 11.0 AMPS
84	REACH-IN FREEZER	F1A-FS	X	X	-	X	115 VOLTS, 9.0 AMPS / WITH CASTORS / NOTE 09
85	S.S. WORK TABLE 30"W. x 26"D X 30" H	CUSTOM	X	X	-	X	WITH UNDERSHELF
86	S.S. STAND	SK2731U	X	X	-	X	OVEN STAND WITH WHEELS
87	CONVECTION OVEN	E31D4	X	X	-	X	208V, 14 AMPS / NEMA 6-15P CORDSET FITTED / NOTE 10
88	NOT USED	-	-	-	-	-	-
89	NOT USED	-	-	-	-	-	-
90	NOT USED	-	-	-	-	-	-
91	NOT USED	-	-	-	-	-	-
92	MANAGER'S DESK	CUSTOM	X	X	-	X	COORDINATE WITH EQUIPMENT MANUFACTURER
93	NOT USED	-	-	-	-	-	-
94	NOT USED	-	-	-	-	-	-
95	NOT USED	-	-	-	-	-	-
96	NOT USED	-	-	-	-	-	-
97	NACHO CHEESE DISPENSER	GEHLS	N/A	X	-	X	PROVIDED BY CHEESE DISPENSER COMPANY
98	STAINLESS STEEL CORNER GUARD	N/A	-	X	-	X	-
99	STAINLESS STEEL END CAP	N/A	-	X	-	X	-
100	FREEZER SHELVING	EG01.00	X	X	-	X	FF1836G 4 TIERS HIGH, FG063G POSTS
101	DARPRO COOKING OIL COLLECTION	FAT4FUEL	X	X	-	X	-

EQUIPMENT LEGEND NOTES:

1. FLAT PANEL TV DISPLAY WALL MOUNTING BRACKET & MONITOR BRAND SELECTION TO BE DETERMINED BY OWNER. CONTRACTOR TO COORDINATE ITEM #58 WITH OWNER FOR INSTALLATION.

2. THE OWNER SHALL PROVIDE WALL MOUNTED DECOR ITEMS. THESE ITEMS ARE TO BE INSTALLED BY THE CONTRACTOR. THE CONTRACTOR SHALL COORDINATE AND SCHEDULE THE DELIVERY AND INSTALLATION OF ALL DECOR ITEMS WITH THE OWNER. REFER TO A3.1

3. THE CONTRACTOR SHALL VERIFY WITH ALL LOCAL AGENCIES QUANTITY AND LOCATION OF ALL FIRE EXTINGUISHERS.

4. ALL KITCHEN EQUIPMENT SHALL MEET THE REQUIREMENTS OF THE NATIONAL SANITATION FOUNDATION (NSF).

5. THE EXHAUST HOOD, EXHAUST FAN, EXHAUST DUCT, EXHAUST DUCT FIRE WRAP AND MAKE-UP AIR FAN SHALL BE SUPPLIED BY THE OWNER AND INSTALLED BY THE CONTRACTOR. THE MAKE-UP AIR DUCT SHALL BE SUPPLIED AND INSTALLED BY THE CONTRACTOR.

6. THE EXHAUST HOOD FIRE SUPPRESSION SYSTEM SHALL BE SUPPLIED AND INSTALLED BY THE OWNER. THE CONTRACTOR SHALL SUPPLY AND INSTALL THE EMERGENCY GAS SHUT-OFF VALVE

7. THE CONTRACTOR SHALL COORDINATE AND SCHEDULE THE DELIVERY OF ALL KITCHEN EQUIPMENT WITH THE EQUIPMENT VENDOR.

8. THE CONTRACTOR SHALL MAKE ALL FINAL ELECTRICAL CONNECTIONS REQUIRED FOR THE OWNER PROVIDED SIGNAGE.

9. ALL SPECIFIED REFRIGERATION UNITS SHALL BE SELF-CONTAINED AND SELF EVAPORATING.

10. NO GREASE LADEN FOODS SHALL BE PREPARED IN THE CONVECTION OVEN (ITEM #87), IT IS USED FOR BAKING ROLLS ONLY.

11. CONTACT SMARTRACK 9U WALL-MOUNT RACK SUPPLIER FOR ADDITIONAL INFORMATION: CHRIS IANNUZZI OF IT SAVVY (630) 396-6315

EQUIP. PLAN NOTES

1. ALL SWITCHES, COVER PLATES, AND PLUGS SHALL BE 'WHITE'

2. TELEPHONE SERVICE SHALL BE (3) THREE LINES OF SERVICE AS FOLLOWS:

- LINE 1 SHALL BE PRIMARY TELEPHONE LINE.
- LINE 2 SHALL BE FOR ROLL-OVER TELEPHONE LINE AND FAX LINE.
- LINE 3 SHALL BE FAX AND DATA LINE.

3. THE GENERAL CONTRACTOR SHALL PROVIDE THE MOUNTING OF TRANSFORMERS AND FINAL ELECTRICAL CONNECTION OF THE OWNER PROVIDED AND INSTALLED INTERIOR AND EXTERIOR BUILDING SIGNAGE. ALL SIGNS SHALL BE ON INDIVIDUAL CIRCUITS WITH DEDICATED GROUNDS.

4. THE FLOOR SINK UNDER THE 3-COMPARTMENT SINK IS USED FOR THE PLUMBING HOSE BIB.

5. COOKING AREA PROTECTION SYSTEM SHALL BE SUBMITTED FOR PLAN REVIEW UNDER A SEPARATE PLAN CHECK AND PERMIT

NOTE: EXTERIOR SIGNAGE SHALL BE SUBMITTED UNDER A SEPARATE PLAN CHECK REVIEW AND PERMIT PROCESS.

EQUIP. PLAN LEGEND

- PROVIDE DEDICATED CIRCUIT AND GROUND 12'-0" A.F.F. ABOVE SOFFIT FOR LED SIGNS - TYPICAL - REFER TO ELECTRICAL DRAWINGS FOR ADDITIONAL INFORMATION
- PROVIDE DEDICATED CIRCUIT AND GROUND WITH CIRCUIT TIMER FOR EXTERIOR BUILDING SIGN - TYPICAL - VERIFY LOCATION WITH SIGN VENDOR - REFER TO ELECTRICAL DRAWINGS FOR ADDITIONAL INFORMATION
- REMOTE ANSUL PULL STATION - VERIFY LOCATION WITH LOCAL FIRE MARSHAL
- GAS SERVICE CONNECTION - REFER TO MECHANICAL DRAWINGS FOR ADDITIONAL INFORMATION
- 6" P.V.C. BEVERAGE CONDUIT RUN IN CEILING WITH 6" 90'S AND 6" P.V.C. IN PARTITIONS - REFER TO DETAIL 7/EQ2 FOR ADD. INFO.


WALK-IN COOLER/FREEZER SPECIFICATIONS

COMPONENT	DESCRIPTION
INSULATION:	FOAMED IN-PLACE U.L. LISTED, CLASS 1 URETHANE FOAM INSULATION WITH A FLAME SPREAD RATING OF LESS THAN 25, AND SMOKE DENSITY OF LESS THAN 450 - WGBB TESTED IN ACCORDANCE TO A.S.T.M. E84 (U.L. 723)
FLOOR:	FLOOR, WALL, AND CEILING PANELS: 4" THICK HIGH DENSITY PRE-FABRICATED FRAME - N.S.F. COVERED, STEP-UP @ FREEZER FLOOR ONLY
FINISH:	INTERIOR: 26 GA. STUCCO EMBOSSED GALVALUM EXTERIOR: 26 GA. STUCCO EMBOSSED GALVALUM FLOOR FINISH: #10 SMOOTH ALUMINUM
DOORS:	(1) 34" x 78" FLUSH-IN FITTING COOLER DOOR (1) 30" x 72" FLUSH-IN FITTING FREEZER DOOR

1. INSTALLATION INSTRUCTIONS FOR THE WALK-IN COOLER/FREEZER SHALL BE ON THE JOBSITE FOR THE LOCAL BUILDING OFFICIAL

2. PROVIDE CP 25WB+ FIRE BARRIER SEALANT CAULK OR FB-3000 W/IT FIRE BARRIER SEALANT FOR ANY PENETRATIONS INTO THE INSULATED PANELS

NOTE:
REFER TO A0.0 FOR GENERAL NOTES
AND NOTES TO BIDDERS

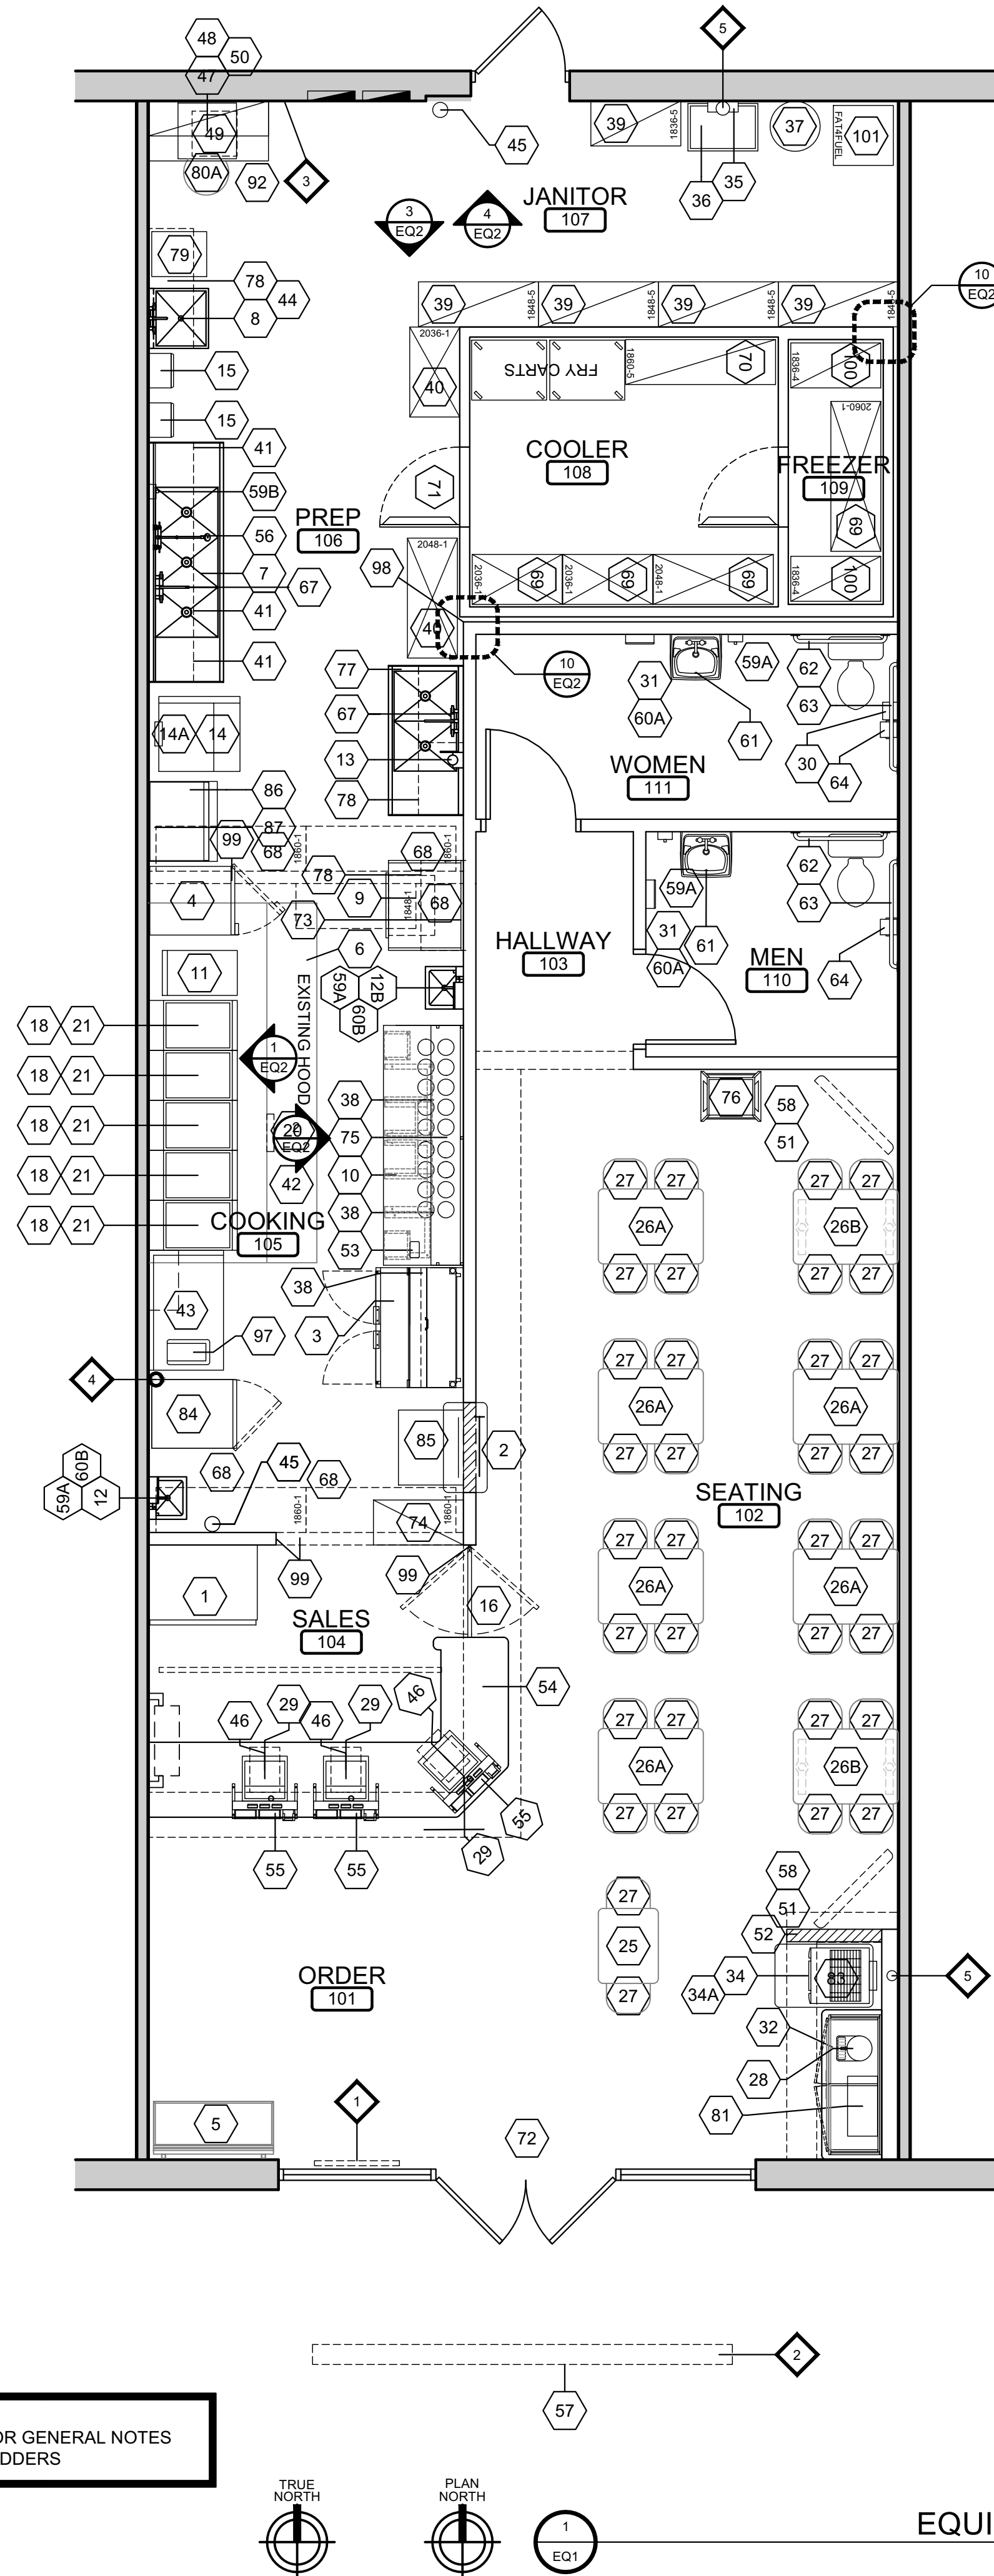

EQUIPMENT PLAN

1/4\"=1'-0"

CONSULTANT:



15 Ninth Avenue North, Hopkins, MN 55343
Phone: 952.941.8650 / www.wilkusarch.com

CLIENT:



15505 WRIGHT BROTHERS DRIVE
ADDISON, TX 75001
TELEPHONE: (972) 686-6500
FAX: (972) 686-6502

DISCLAIMER:

THESE DRAWINGS, IDEAS, SPECIFICATIONS AND DESIGNS ARE EXCLUSIVE PROPERTY OF WINGSTOP RESTAURANTS, INC. NO PART OF THESE DRAWINGS MAY BE COPIED, REPRODUCED, OR OTHERWISE USED BY ANY OTHER PARTY WITHOUT THE WRITTEN CONSENT OF WINGSTOP RESTAURANTS, INC.

COPYRIGHT (c) 2013
WINGSTOP RESTAURANTS, INC.
ALL RIGHTS RESERVED

PROJECT INFORMATION:

WING-STOP
STORE NUMBER: GL#Y085
STONE CREST PLAZA
2814 LEE BOULEVARD, SUITE 10
LEHIGH ACRES, FL 33971

SEAL:

MATTHEW M. WILKUS, ARCHITECT
LICENSE NUMBER: AR99000
EXPIRATION DATE: 02-28-23

10-21-21
DATE

PROJECT NO.: 2020-0591

DRAWN BY: JGL

CHECKED BY: JSS

ISSUE: DATE:

PERMIT & BID SET 10-21-21

REVISION: DATE:

PROJECT LOCATION:

LEHIGH ACRES, FL

SHEET NUMBER / TITLE:

EQ1

EQUIPMENT PLAN